


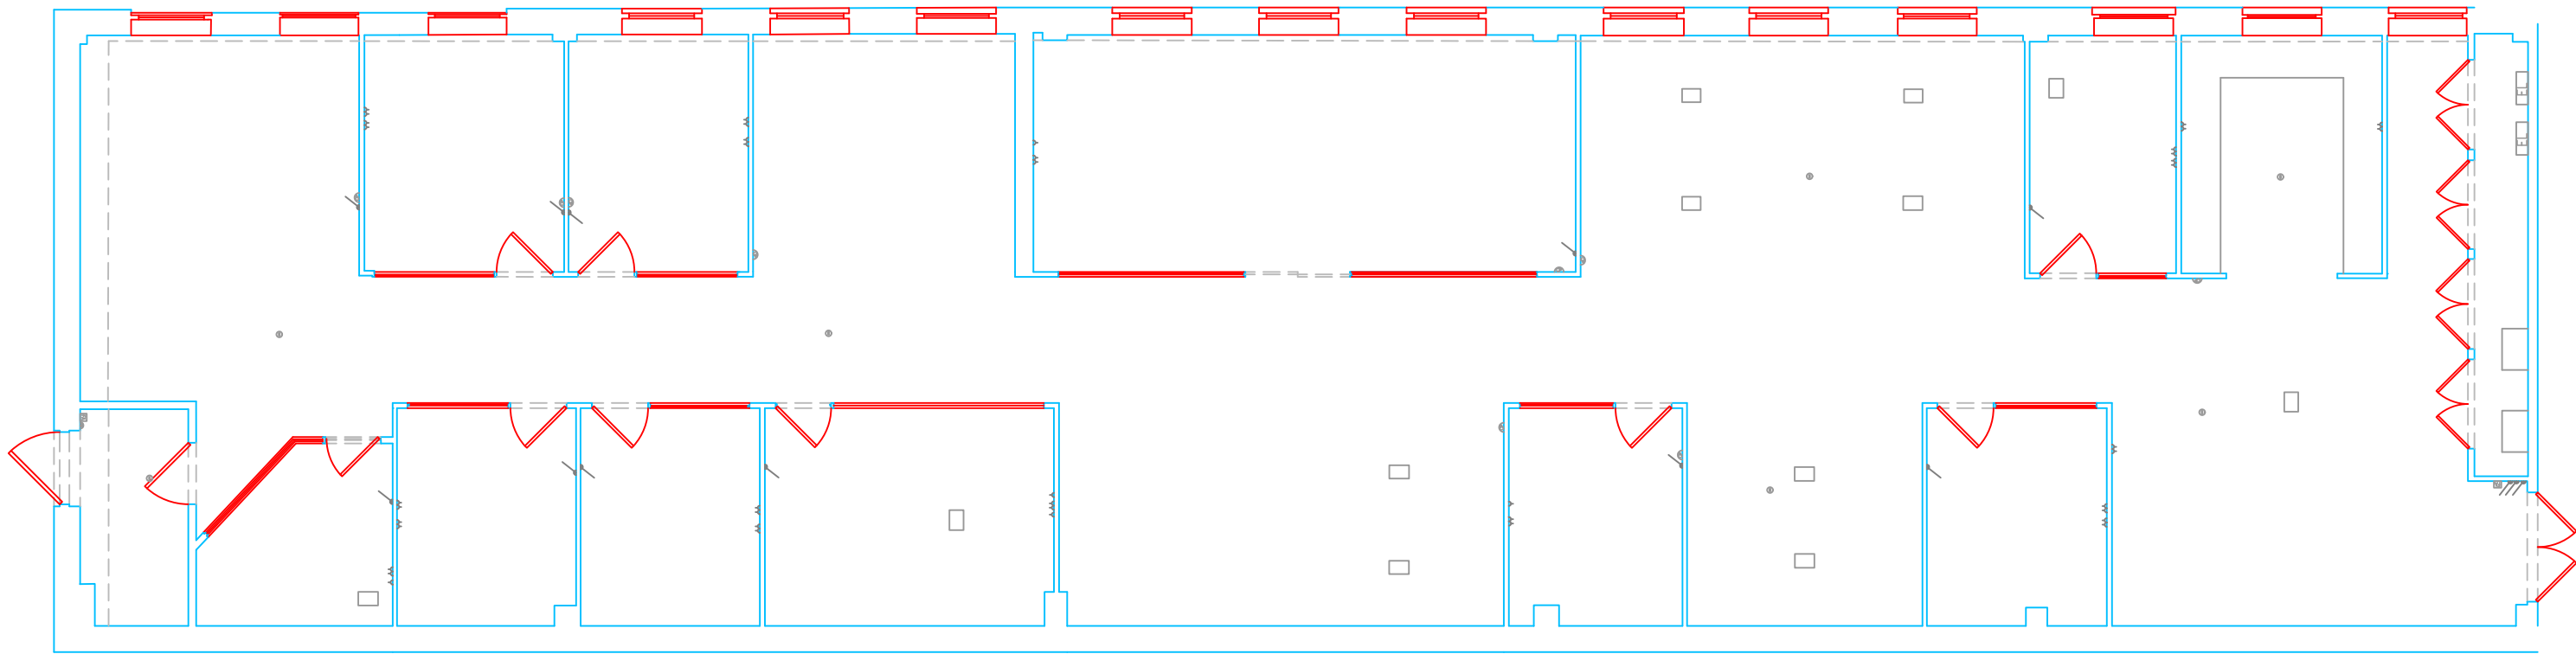

Legend:			
Abbreviated Features:	Symbols:		
AB Air Brick	LI Light	Rodotor	
B Balcony	O/F Overflow Pipe	Light	
C/B Close Boarded	P Post	Emergency Light	
C/H Cill to Head	P/C Pitched Ceiling	Strip Light	
C/L Chain Link	PE Pipe	Wall Mounted Light	
CL Ceiling Level	P/R Pitched Roof	Mains Point	
CPD Cupboard	P/W Post & Wire	Blank Plate	
CR Crown Point Level	RD Roller Door	Light Switch	
DH Door Height	RE Roofing Eave	Isolator Switch	
Dr Drain	RWP Rainwater Pipe	Alarm Bell	
FE Fire Exit	SD Sliding Door	Fire Alarm Push	
F-C Floor to Cill	SSCL Suspended Ceiling Level	Smoke Detector	
FL Floor Level	SP Spring Point Level	Alarm Panel	
FW Foul Water	SVP Soil & Vent Pipe	Thermostat	
MH Manhole	SW Surface Water	Modern	
G Gully	US Underside	Fuse Box	
IC Inspection Chamber	UL Unload To Lift	Electric Box	
L Level	VP Vent Pipe	Water Stop Tap	
I/R Iron Railings	VI Vent	Downhead Features	
		Control Panel	
		Dado	

Plan Coordinate Control:-- N/A
Level Datum:-- All Levels relate to OSGB36 using GPS

Key:

Notes:

REV B Layers removed	19/01/26	S.JH
REV A G/A removed	04/09/25	S.JH
REV NO REV NOTE	DATE	SIGNED





3 Brookfield, Duncan SClose,
Moulton Park, Northampton, NN3 6WL
Tel: 01604 491543
Email: info@globalsurveys.co.uk

Site:	Whitehead First Floor West – North Oxford Science Park OX4 4GA
Client:	The Oxford Science Park (Properties) No. 1 Ltd
Survey Title:	Measured Building Survey Floor Plan

Date	August 2025	Scale	1/100	⊙ A1
Dwg No.	25142-MBS	Surveyor	EJ	
Sheet	1 of 1	Checked	S.JH	