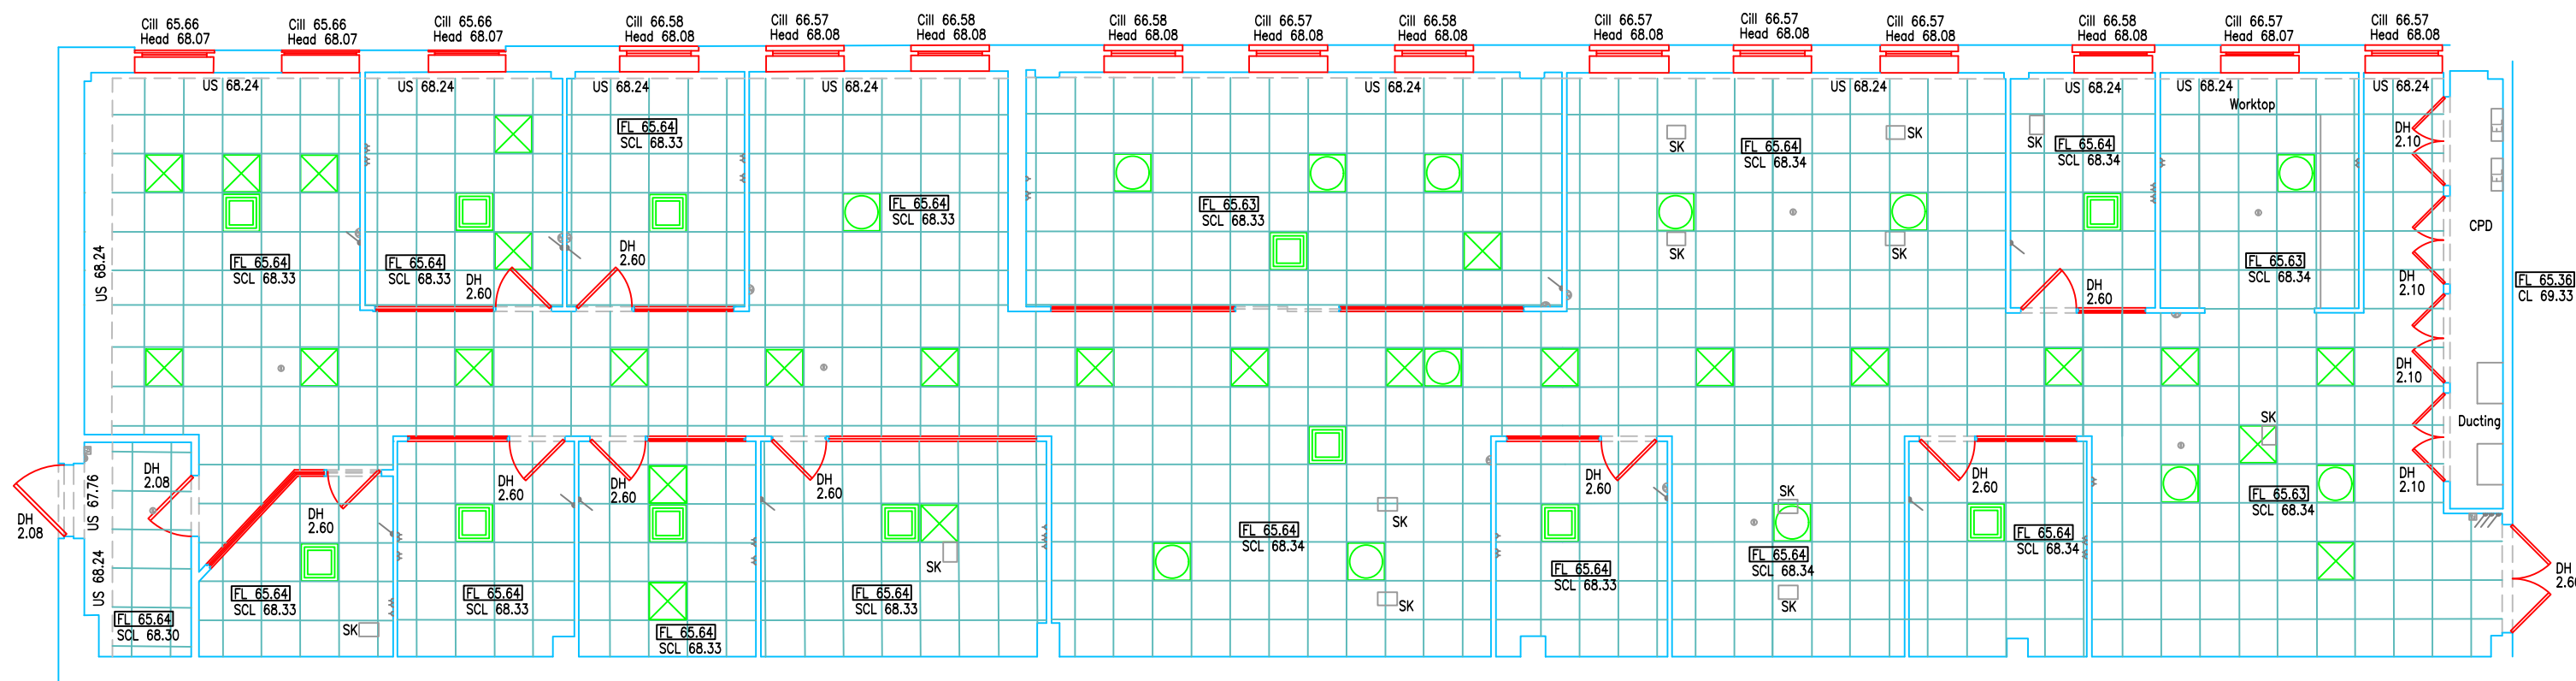


Legend:	
Abbreviated Features:	
AB	Air Brick
B	Balloon
C/B	Close Boarded
C-H	Cill to Head
C/L	Chain Link
SCL	Ceiling Level
CPD	Cupboard
CR	Crown Point Level
DH	Door Height
Dr	Drain
FE	Fire Exit
F-C	Floor to Cill
FL	Floor Level
FW	Foul Water
MH	Manhole
G	Gully
IC	Inspection Chamber
IL	Invert Level
I/R	Iron Railings
LI	Light
O/F	Overflow Pipe
P	Post
P/C	Pitched Ceiling
PE	Pipe
P/R	Pitched Roof
F/W	Post & Wire
RD	Roller Door
RE	Recessing Eye
RWP	Rainwater Pipe
SD	Sliding Doors
SSCL	Suspended Ceiling Level
SP	Spring Point Level
SVP	Soil & Vent Pipe
SK	Socket
SW	Surface Water
US	Underside
UTL	Unable To Lift
VP	Vent Pipe
VI	Vent
Rodator	
Emergency Light	
Strip Light	
Wall Mounted Light	
Mains Point	
Blank Plate	
Light Switch	
Isolator Switch	
Alarm Bell	
Fire Alarm Push	
Smoke Detector	
Alarm Panel	
Thermostat	
Modern	
Fuse Box	
Electric Box	
Heater	
Water Stop Top	
Overhead Features	
Control Panel	
Dado	

Plan Coordinate Control:-
N/A

Level Datum:-
All Levels relate to OSGB36 using GPS

Key:

Notes:

REV A	GIA removed	04/09/25	SJH
REV NO	REV NOTE	DATE	SIGNED





GLOBAL SURVEYS

3 Brookfield, Duncan SClose,
Moulton Park, Northampton, NN3 6WL
Tel: 01604 491543
Email: info@globalsurveys.co.uk

Site:	Whitehead First Floor West – North Oxford Science Park OX4 4GA
Client:	The Oxford Science Park (Properties) No. 1 Ltd
Survey Title:	Measured Building Survey Floor Plan

Date	August 2025	Scale	1/100 @ A1
Dwg No.	25142-MBS	Surveyor	EJ
Sheet	1 of 1	Checked	SJH