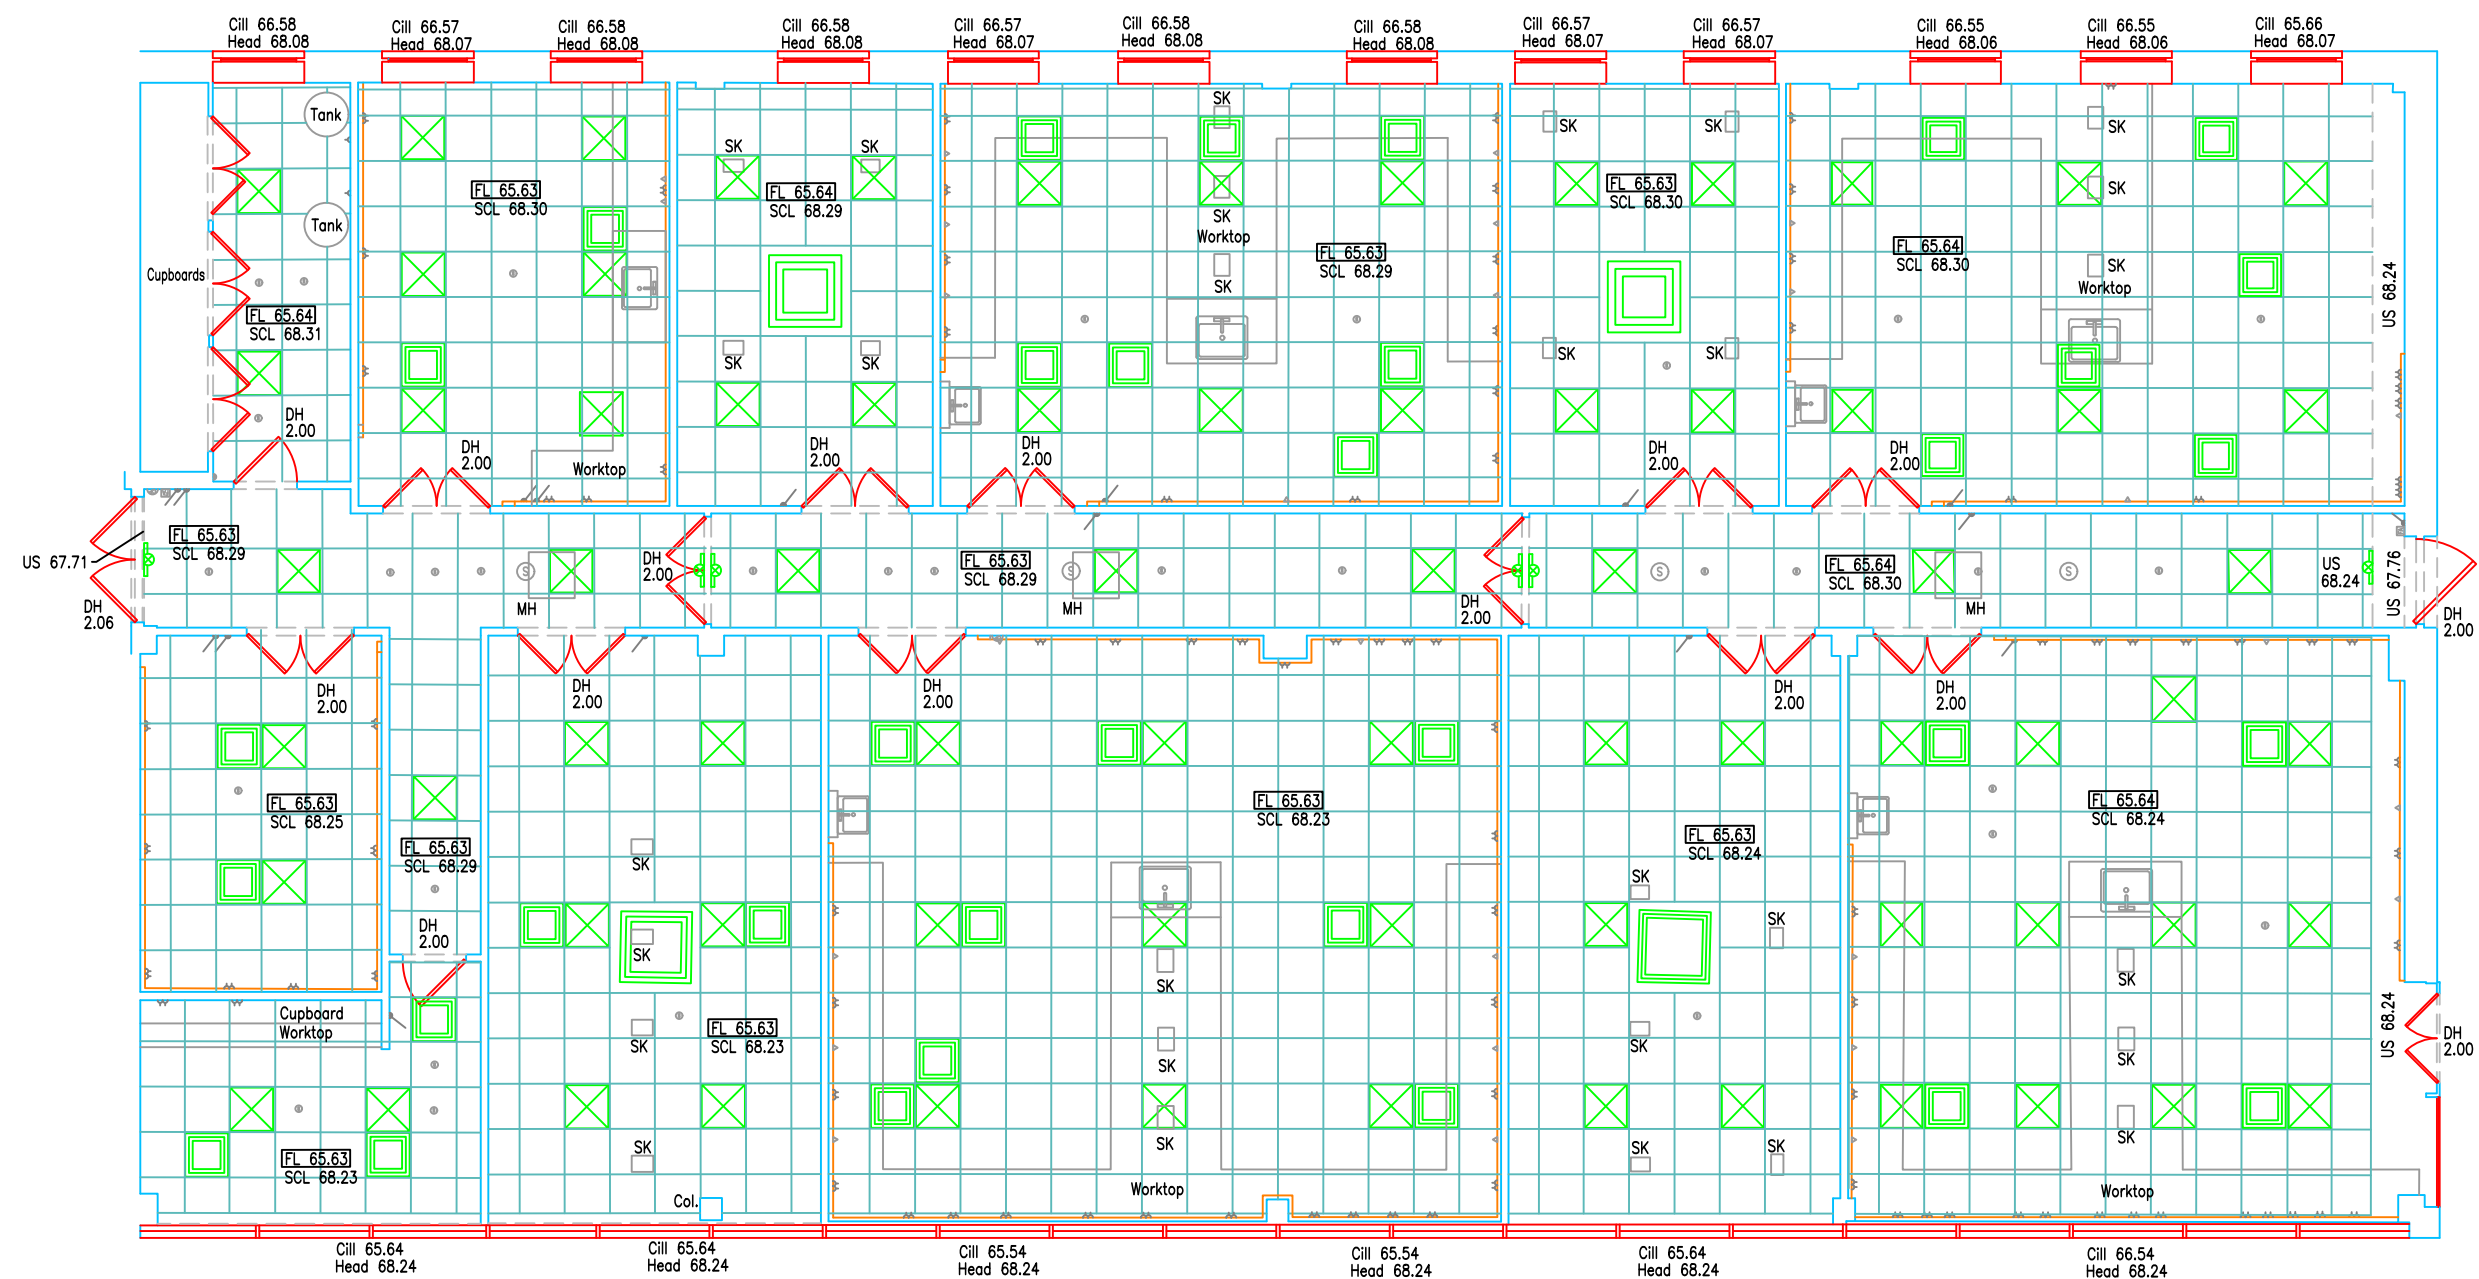


Legend:		
Abbreviated Features:	Symbols:	
AB Air Brick	LI Light	Rodator
B Balcony	O/F Overflow Pipe	Light
C/B SClose Boarded	P Post	Emergency Light
C/H Cill to Head	P/C Pitched Ceiling	Strip Light
C/L Chain Link	PE Pipe	Wall Mounted Light
SCL Ceiling Level	P/R Pitched Roof	Mains Point
CPD Cupboard	F/W Post & Wire	Blank Plate
CR Crown Point Level	RD Roller Door	Light Switch
DH Door Height	RE Rainwater Pipe	Isolator Switch
Dr Drain	RWP Rainwater Pipe	Alarm Bell
FE Fire Exit	SD Sliding Door	Fire Alarm Push
F-C Floor to Cill	SSCL Suspended Ceiling Level	Alarm Panel
FL Floor Level	SP Spring Point Level	Thermistor
FW Foul Water	SVP Soil & Vent Pipe	Smoke Detector
MH Manhole	SK Socket	Alarm Panel
G Gully	SW Surface Water	Thermistor
IC Inspection Chamber	US Underside	Smoke Detector
IL Invert Level	UTL Unable To Lift	Alarm Panel
I/R Iron Railings	VP Vent Pipe	Thermistor
	VI Vent	Modern
		Fuse Box
		Electric Box
		Water
		Water Stop Top
		Overhead Features
		Control Panel
		Dado

Plan Coordinate Control:-
N/A


Level Datum:-
All Levels relate to OSGB36 using GPS

Key:

Notes:

REV A	GIA removed	04/09/25	SJH
REV NO	REV NOTE	DATE	SIGNED



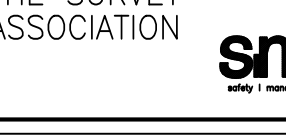





3 Brookfield, Duncan SClose,
Moulton Park, Northampton, NN3 6WL
Tel: 01604 491543
Email: info@globalsurveys.co.uk

Site:	Whitehead First Floor East Oxford Science Park OX4 4GA
Client:	The Oxford Science Park (Properties) No. 1 Ltd
Survey Title:	Measured Building Survey Floor Plan

Date	August 2025	Scale	1/100 @ A1
Dwg No.	25143-MBS	Surveyor	EJ
Sheet	1 of 1	Checked	SJH