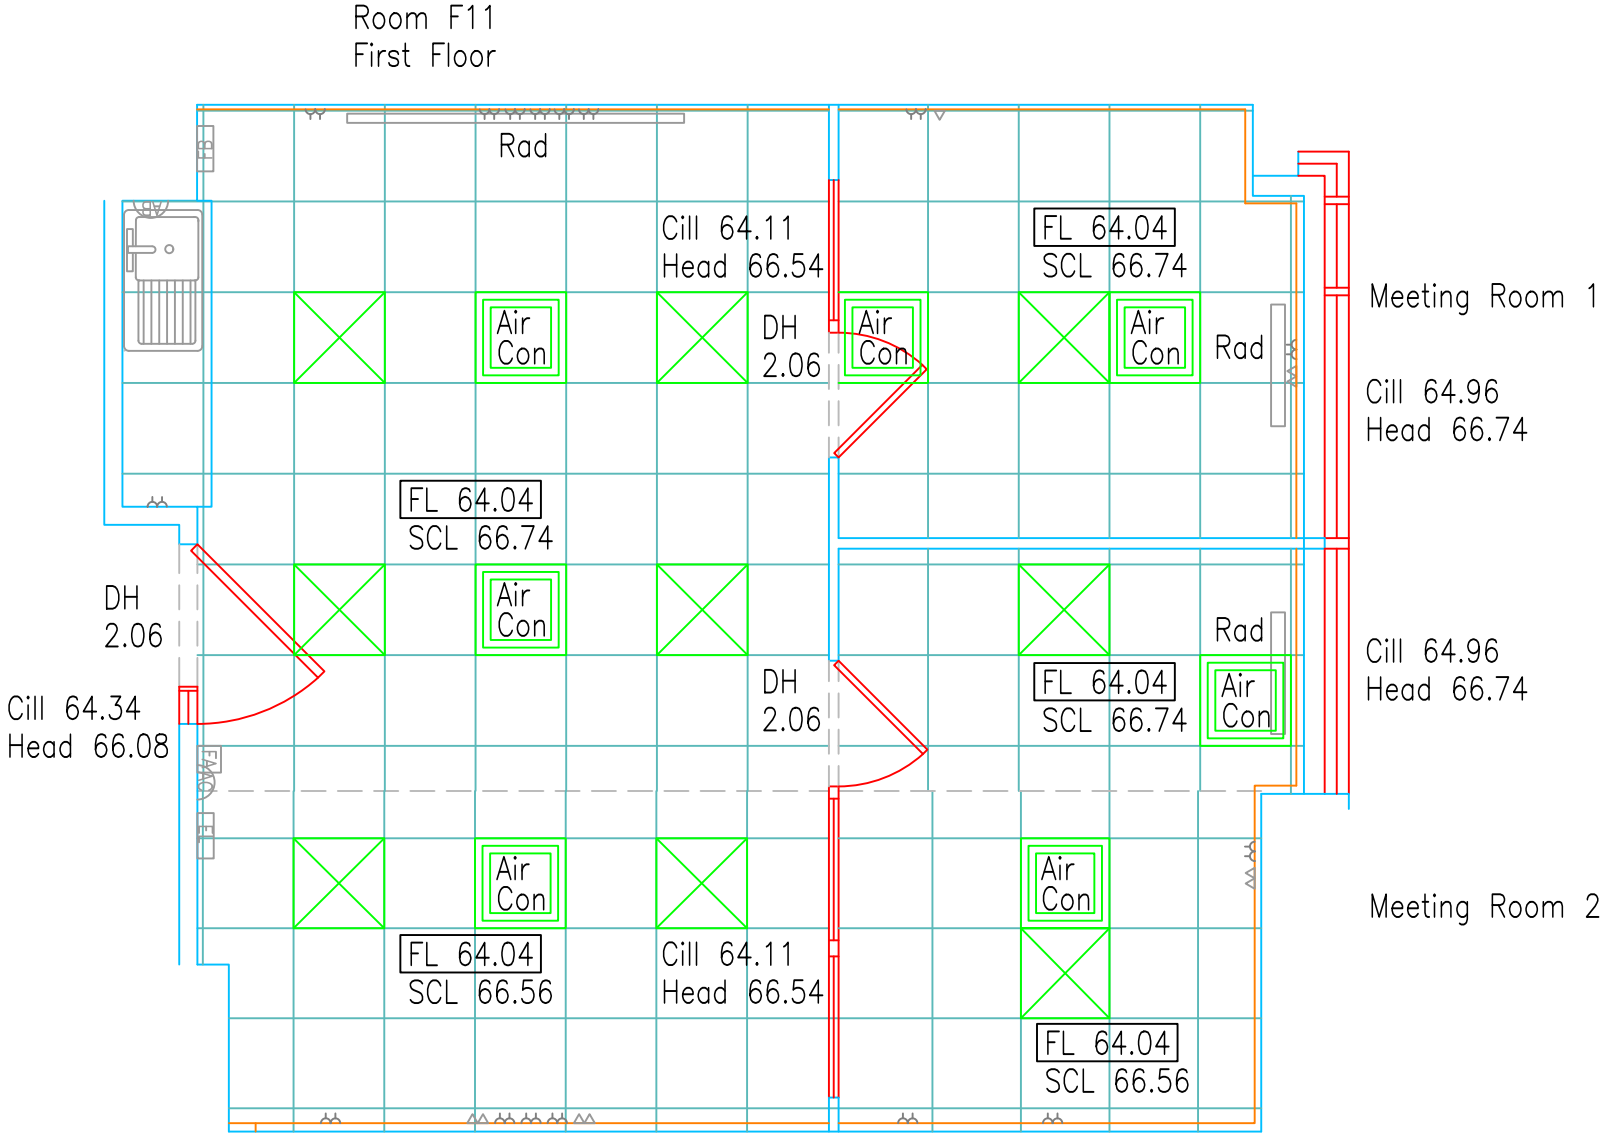


Legend:

Abbreviated Features:	Symbol:
AB Air Brick	Rad
B Bollard	Light
C/B Close Boarded	Emergency Light
C-H Cill to Head	Strip Light
C/L Chain Link	Wall Mounted Light
CL Ceiling Level	Main Point
CPD Cupboard	Blank Plate
CR Crown Point Level	Light Switch
DH Door Height	Pendant Switch
Dr Drain	Isolator Switch
FE Fire Exit	Alarm Bell
F-C Floor to Cill	Fire Alarm Push
FL Floor Level	Smoke Detector
FW Foul Water	Alarm Panel
G Gully	Thermistat
IC Inspection Chamber	Modern
IL Invert Level	Fuse Box
I/R Iron Railings	Electric Box
	Heater
	Water Stop Top
	Overhead Features
	Control Panel
	Dado

Plan Coordinate Control:-
N/A

Level Datum:-
All Levels relate to OSGB36 using GPS

Key:

Notes:

REV A	GIA removed	04/09/25	SJH
REV NO	REV NOTE	DATE	SIGNED



GLOBAL SURVEYS

3 Brookfield, Duncan Close,
Moulton Park, Northampton, NN3 6WL
Tel: 01604 491543
Email: info@globalsurveys.co.uk

Site:	The Magdalen Centre, First Floor, F11 Oxford Science Park OX4 4GA
Client:	The Oxford Science Park (Properties) No.1 Ltd
Survey Title:	Measured Building Survey Floor Plans

Date	August 2025	Scale	1/50 @ A3
Dwg No.	25146-MBS	Surveyor	JR
Sheet	1 of 1	Checked	SJH