
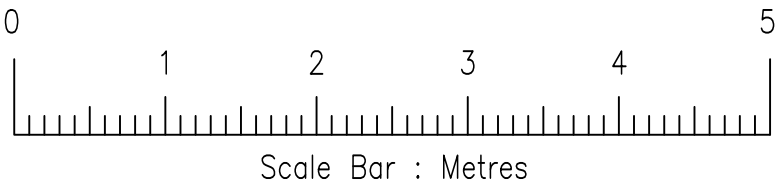
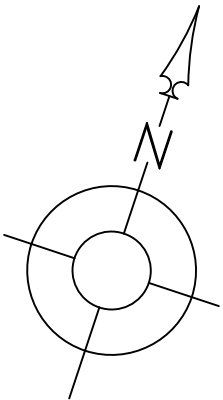


Room F2
First Floor

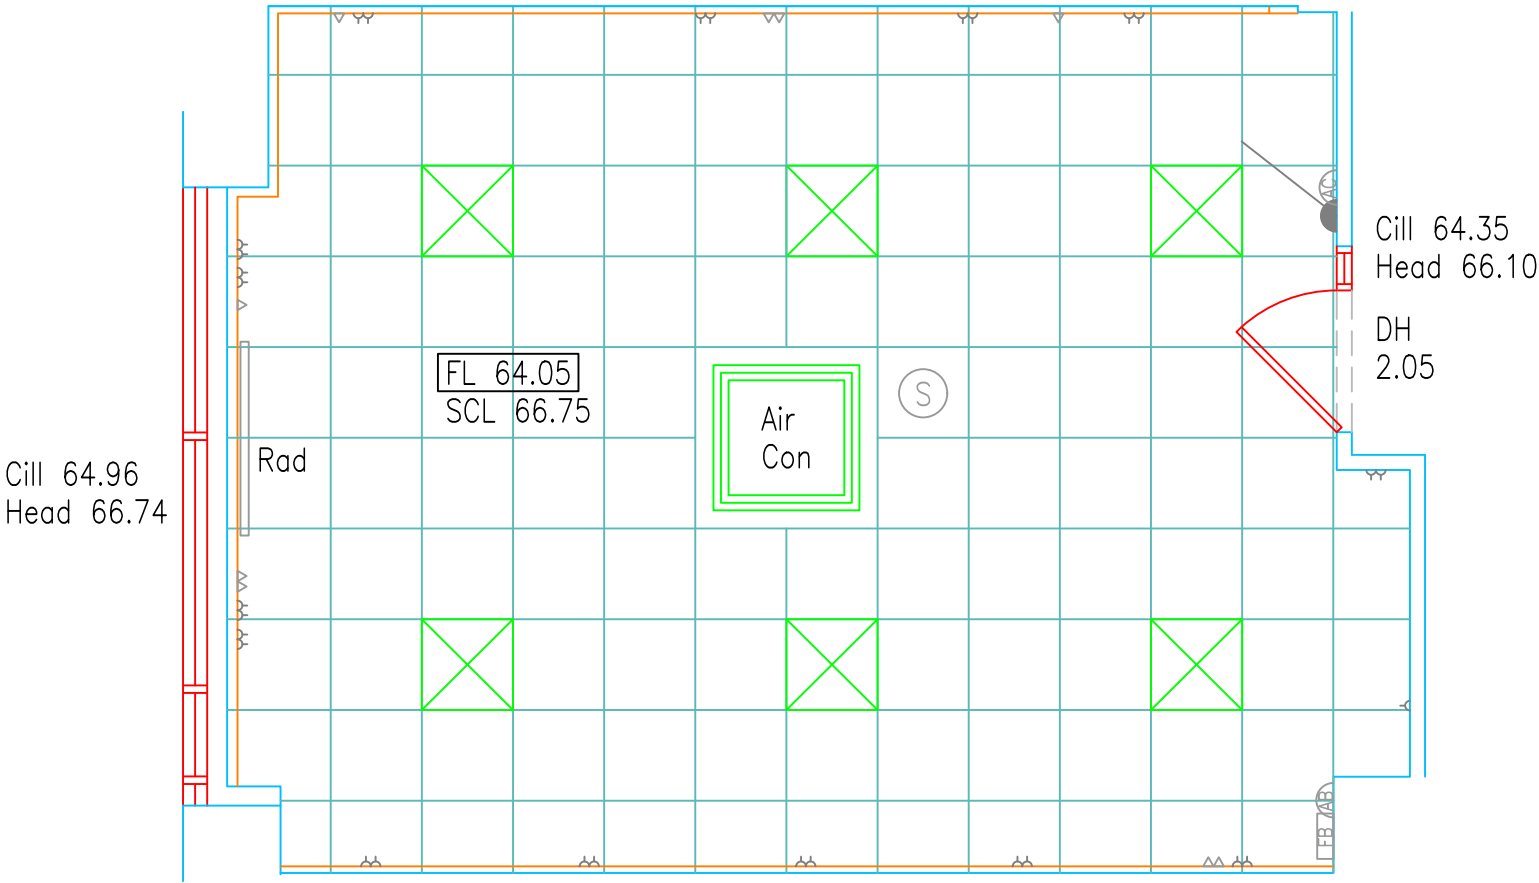

Legend:		
Abbreviated Features:	Symbol:	
AB Air Brick	Lt Light	Radiator
B Bollard	O/F Overflow Pipe	Emergency Light
C/B Close Boarded	P Post	Strip Light
C-H Cill to Head	P/C Pitched Ceiling	Wall Mounted Light
C/L Chain Link	PE Pipe	Mains Point
CL Ceiling Level	P/R Pitched Roof	Blank Plate
CPD Cupboard	P/W Post & Wire	Light Switch
CR Crown Point Level	RD Roller Door	Pendant Switch
DH Door Height	RE Rodding Eye	Isolator Switch
Dr Drain	RWP Rainwater Pipe	Alarm Bell
FE Fire Exit	SD Sliding Doors	Fire Alarm Push
F-C Floor to Cill	SCL Suspended Ceiling Level	Smoke Detector
FL Floor Level	SP Spring Point Level	Alarm Panel
FW Foul Water	SVP Soil & Vent Pipe	Thermometer
MH Manhole	SW Surface Water	Modern
G Gully	US Underside	Fuse Box
IC Inspection Chamber	UTL Unable To Lift	Electric Box
IL Invert Level	VP Vent Pipe	Heater
I/R Iron Railings	VT Vent	Water Stop Top
		Overhead Features
		Control Panel
		Dado

Plan Coordinate Control:-
N/A

Level Datum:-
All Levels relate to OSGB36 using GPS

Key:

Notes:

REV A	GIA removed	04/09/25	SJH
REV NO	REV NOTE	DATE	SIGNED



GLOBAL SURVEYS

3 Brookfield, Duncan Close,
Moulton Park, Northampton, NN3 6WL
Tel: 01604 491543
Email: info@globalsurveys.co.uk

Site:	The Magdalen Centre, First Floor, F2 Oxford Science Park OX4 4GA
Client:	The Oxford Science Park (Properties) No.1 Ltd
Survey Title:	Measured Building Survey Floor Plans

Date	August 2025	Scale	1/50 @ A3
Dwg No.	25145-MBS	Surveyor	JR
Sheet	1 of 1	Checked	SJH