


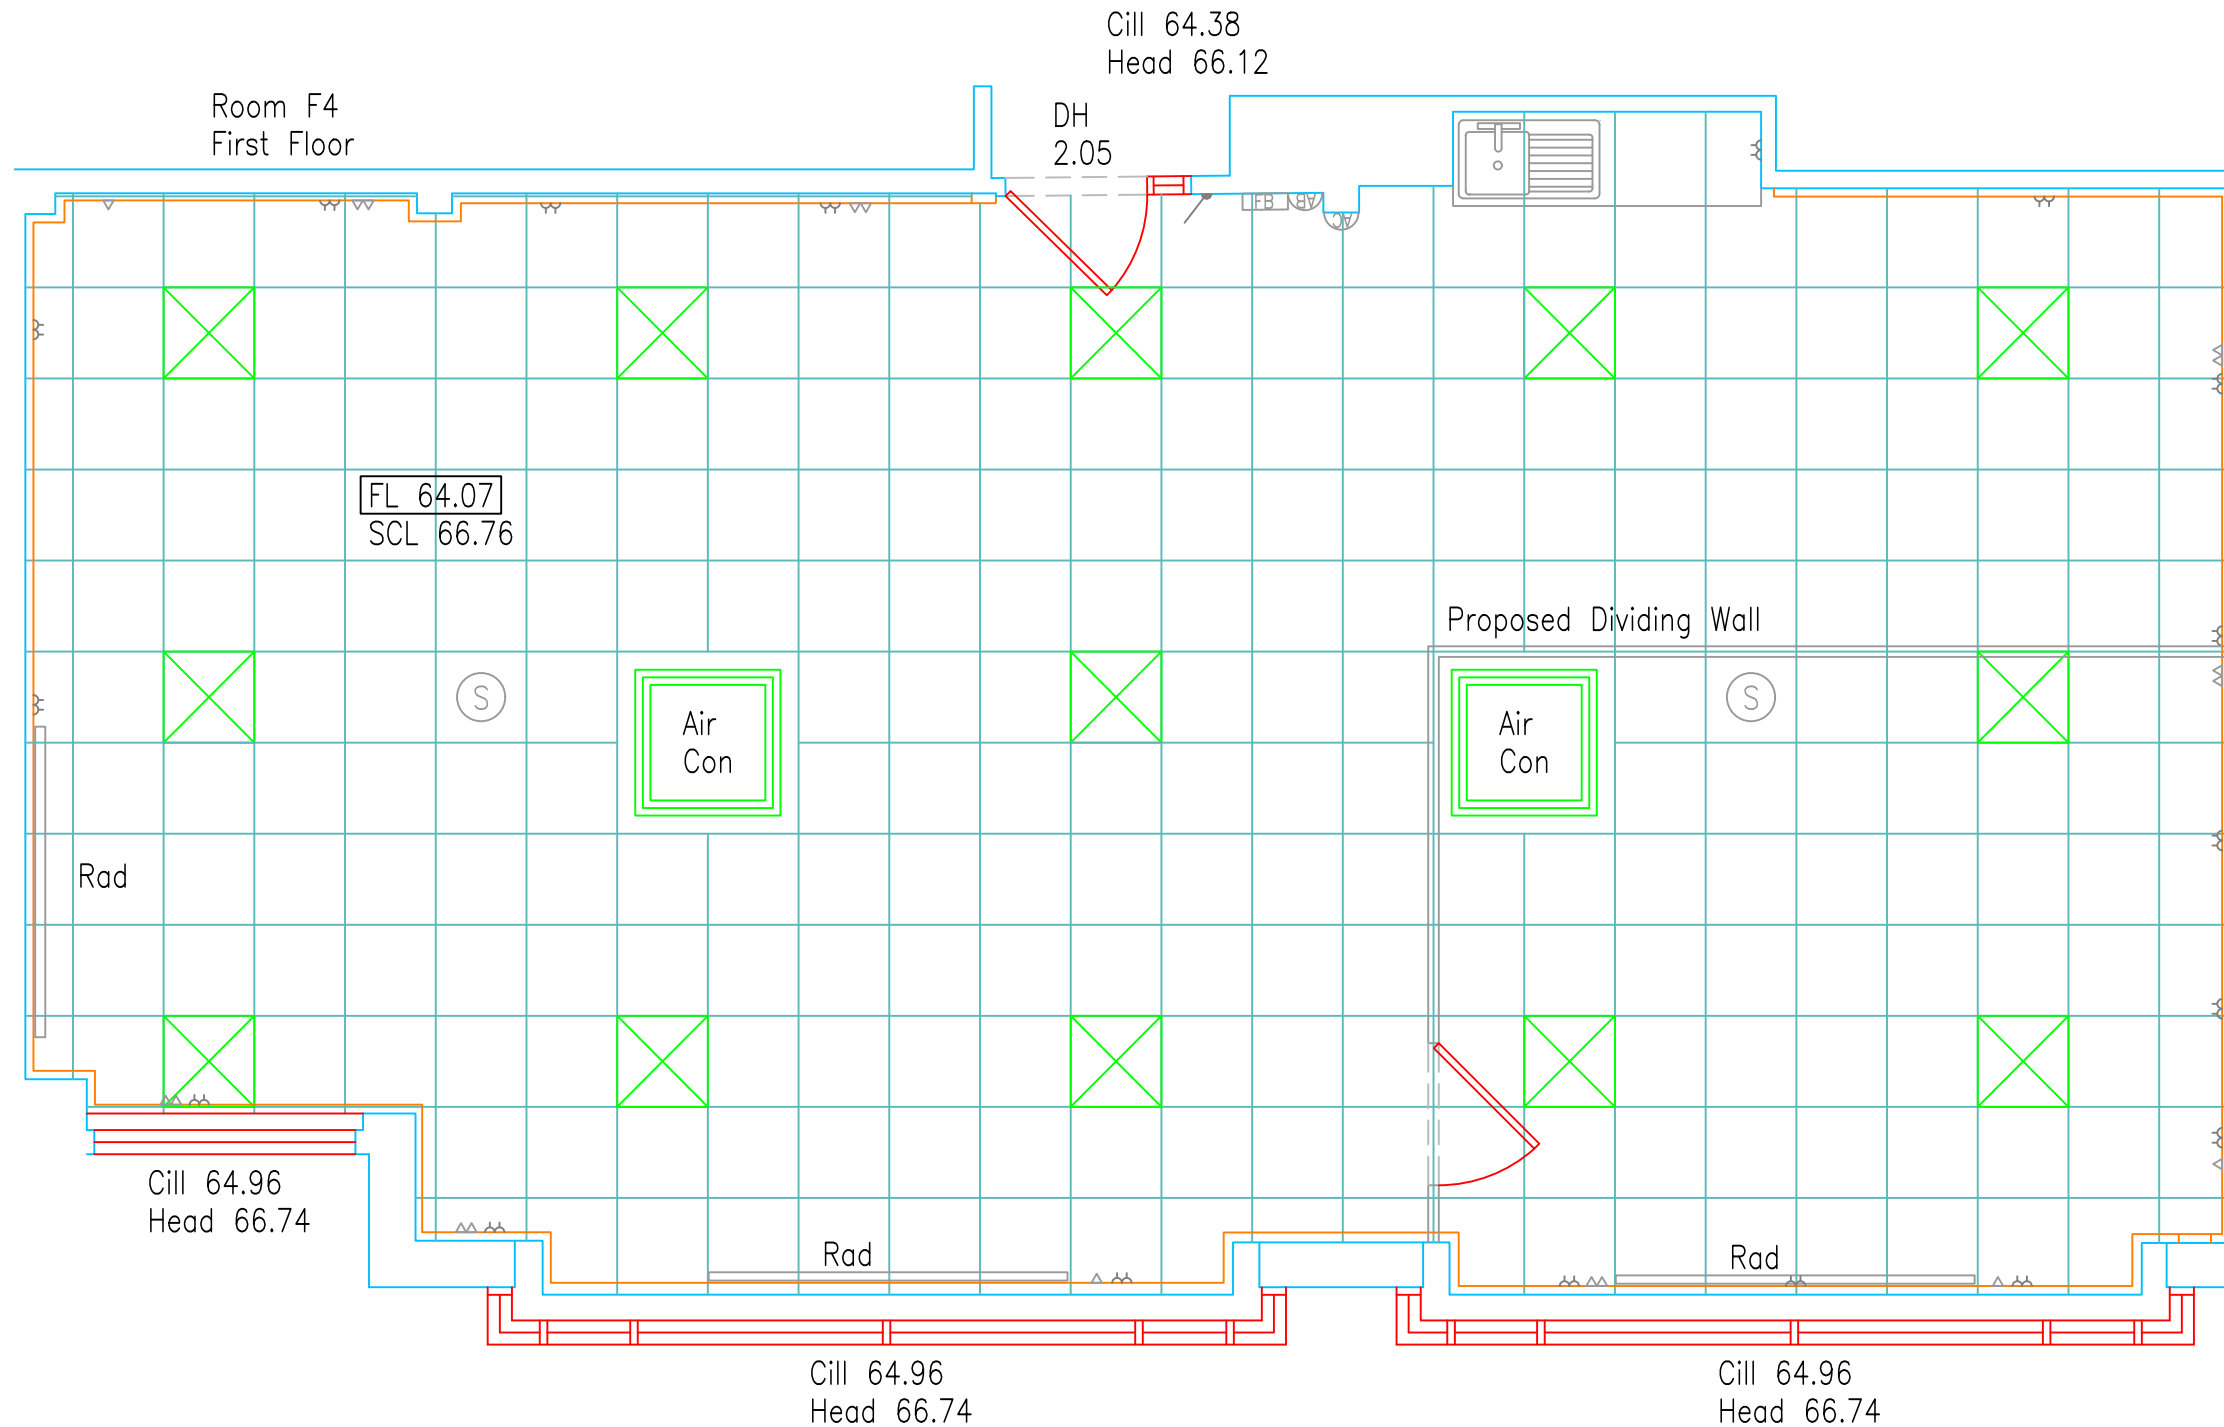

Legend:

Abbreviated Features:	Symbol:
AB Air Brick	Rad
B Bollard	Light
C/B Close Boarded	Emergency Light
C-H Cill to Head	Strip Light
C/L Chain Link	Wall Mounted Light
CL Ceiling Level	Main Point
CPD Cupboard	Blank Plate
CR Crown Point Level	Light Switch
DH Door Height	Pendant Switch
Dr Drain	Isolator Switch
FE Fire Exit	Alarm Bell
F-C Floor to Cill	Fire Alarm Push
FL Floor Level	Smoke Detector
FW Foul Water	Alarm Panel
G Gully	Thermometer
IC Inspection Chamber	Modern
IL Invert Level	Fuse Box
I/R Iron Railings	Electric Box
LT Light	Header
O/F Overflow Pipe	Water Stop Top
P Post	Overhead Features
P/C Pitched Ceiling	Control Panel
PE Pipe	Dado
P/R Pitched Roof	
P/W Post & Wire	
RD Roller Door	
RE Rodding Eye	
RWP Rainwater Pipe	
SD Sliding Doors	
SCL Suspended Ceiling Level	
SP Spring Point Level	
SVP Soil & Vent Pipe	
SW Surface Water	
US Underside	
UTL Unable To Lift	
VP Vent Pipe	
VT Vent	

Plan Coordinate Control:-
N/A

Level Datum:-
All Levels relate to OSGB36 using GPS

Key:

Notes:

REV A	GIA removed	04/09/25	SJH
REV NO	REV NOTE	DATE	SIGNED

RICS **CHAS** **THE SURVEY ASSOCIATION** **smas***

GLOBAL SURVEYS

3 Brookfield, Duncan Close,
Moulton Park, Northampton, NN3 6WL
Tel: 01604 491543
Email: info@globalsurveys.co.uk

Site: The Magdalen Centre, First Floor, F4
Oxford Science Park
OX4 4GA

Client: The Oxford Science Park (Properties)
No.1 Ltd

Survey Title: Measured Building Survey
Floor Plans

Date	August 2025	Scale	1/50 @ A3
Dwg No.	25200-MBS	Surveyor	JR
Sheet	1 of 1	Checked	SJH