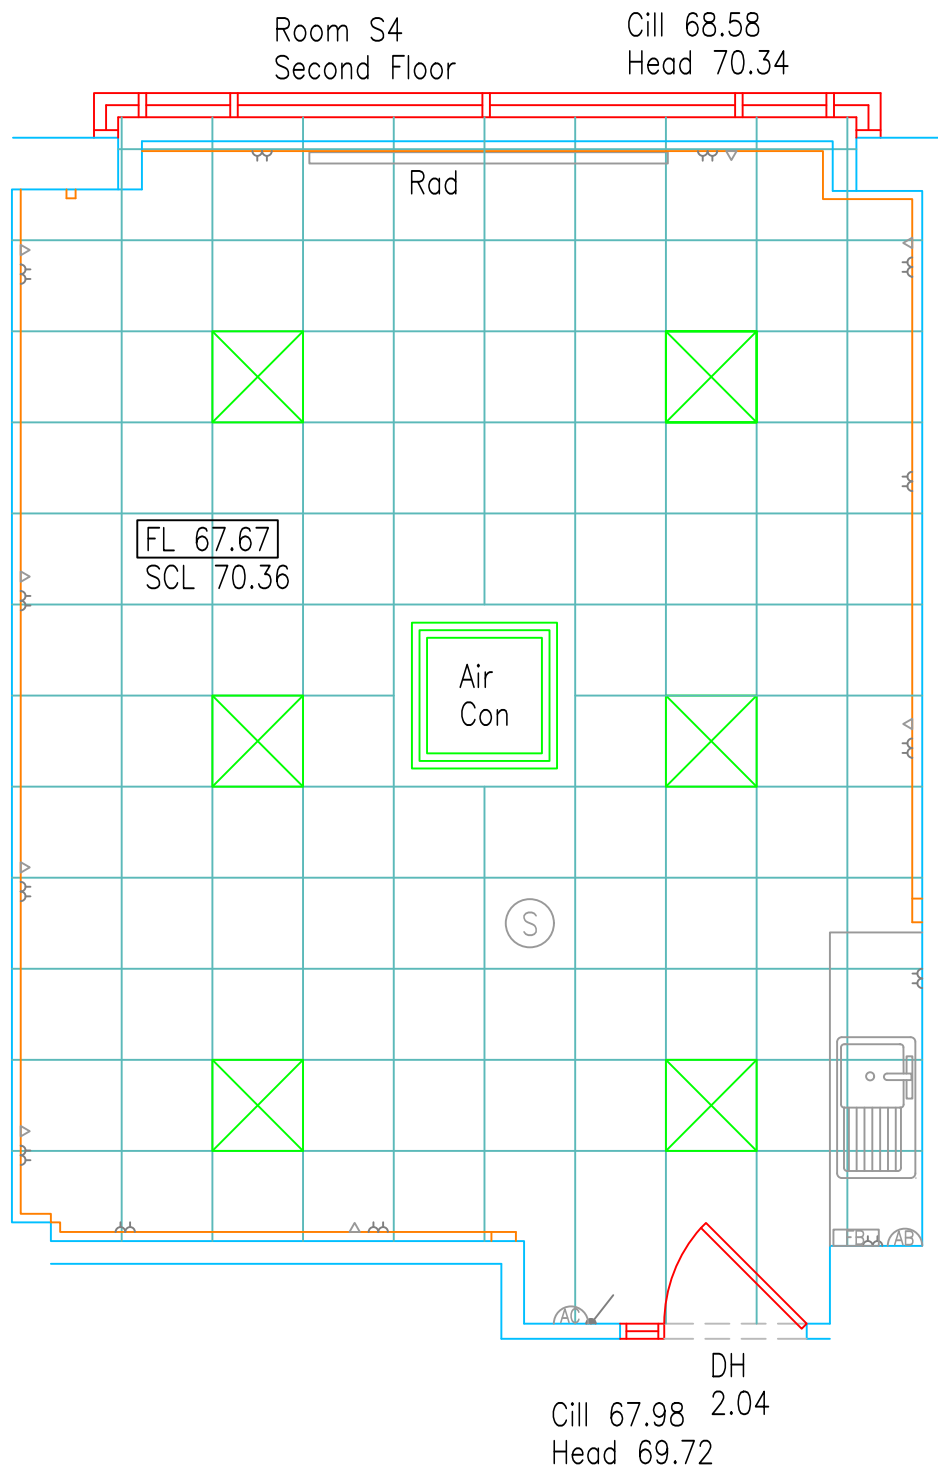


Legend:	
Abbreviated Features:	
AB	Air Brick
B	Bollard
C/B	Close Boarded
C-H	Cill to Head
C/L	Chain Link
CL	Ceiling Level
CPD	Cupboard
CR	Crown Point Level
DH	Door Height
Dr	Drain
FE	Fire Exit
F-C	Floor to Cill
FL	Floor Level
FW	Foul Water
MH	Manhole
G	Gully
IC	Inspection Chamber
IL	Invert Level
I/R	Iron Railings
LT	Light
O/F	Overflow Pipe
P	Post
P/C	Pitched Ceiling
PE	Pipe
P/R	Pitched Roof
P/W	Post & Wire
RD	Roller Door
RE	Rodding Eye
RWP	Rainwater Pipe
SD	Sliding Doors
SCL	Suspended Ceiling Level
SP	Spring Point Level
SVP	Soil & Vent Pipe
SW	Surface Water
US	Underside
UTL	Unable To Lift
VP	Vent Pipe
VT	Vent

Symbols:	
	Radiator
	Light
	Emergency Light
	Strip Light
	Wall Mounted Light
	Mains Point
	Blank Plate
	Light Switch
	Pendant Switch
	Isolator Switch
	Alarm Bell
	Fire Alarm Push
	Smoke Detector
	Alarm Panel
	Thermometer
	Modern
	Fuse Box
	Electric Box
	Heater
	Water Stop Top
	Overhead Features
	Control Panel
	Data

Plan Coordinate Control:-
N/A

Level Datum:-
All Levels relate to OSGB36 using GPS

Key:

Notes:

REV A	GIA removed	04/09/25	SJH
REV NO	REV NOTE	DATE	SIGNED



GLOBAL SURVEYS

3 Brookfield, Duncan Close,
Moulton Park, Northampton, NN3 6WL
Tel: 01604 491543
Email: info@globalsurveys.co.uk

Site:	The Magdalen Centre, Second Floor, S4 Oxford Science Park OX4 4GA
Client:	The Oxford Science Park (Properties) No.1 Ltd
Survey Title:	Measured Building Survey Floor Plans

Date	August 2025	Scale	1/50 @ A3
Dwg No.	25144-MBS	Surveyor	JR
Sheet	1 of 1	Checked	SJH